

LIGHTING SYMBOLS KEY

LIGHT	
	STRAND 6" FRESNELITE
	SELECCON ACCLAIM FRESNEL
	CHAN DIM
	EC-1 2KW
	ETC SOURCE 4 150W
	ETC SOURCE 4 250W
	ETC SOURCE 4 300W
STATIC ACCESSORY	
	C-CLAMP

TYPICAL

COLOR SUMMARY		
COLOR	SIZE	COUNT
R02	6.25"	5
R04	6 1/8" x 6 1/8"	5
R339	6 1/8" x 6 1/8"	3
R39	6 1/8" x 6 1/8"	4
R43	6.25"	3
R51	6 1/8" x 6 1/8"	4
R51	6.25"	14
R68	6.25"	15
R68	6 1/8" x 6 1/8"	4
R14	6 1/8" x 6 1/8"	4
R88	6 1/8" x 6 1/8"	8

LEGEND


PURPOSE

DIMMER #

UNIT #

COLOR


SCALE BAR

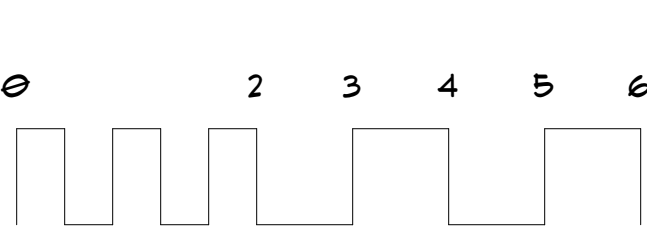

NOTE:

THIS DRAWING REPRESENTS VISUAL CONCEPTS ONLY. THE DESIGNER IS UNQUALIFIED TO DETERMINE THE STRUCTURAL OR ELECTRICAL APPROPRIATENESS OF THIS DESIGN, AND WILL NOT ASSUME RESPONSIBILITY FOR IMPROPER ENGINEERING, CONSTRUCTION, HANDLING, OR USE. ALL MATERIALS AND CONSTRUCTION MUST COMPLY WITH THE MOST STRINGENT APPLICABLE FEDERAL AND LOCAL FIRE, SAFETY, ENERGY, AND ENVIRONMENTAL CODES.

NOTE: THE ADDITION OF COLOR SAVING TOP HATS MAY BE NEEDED FOR ALL DARKER OR MORE SATURATED COLORS IN ORDER TO PROLONG COLOR LIFE. THESE GEL FRAME EXTENDERS SHOULD BE AVAILABLE ON SITE.

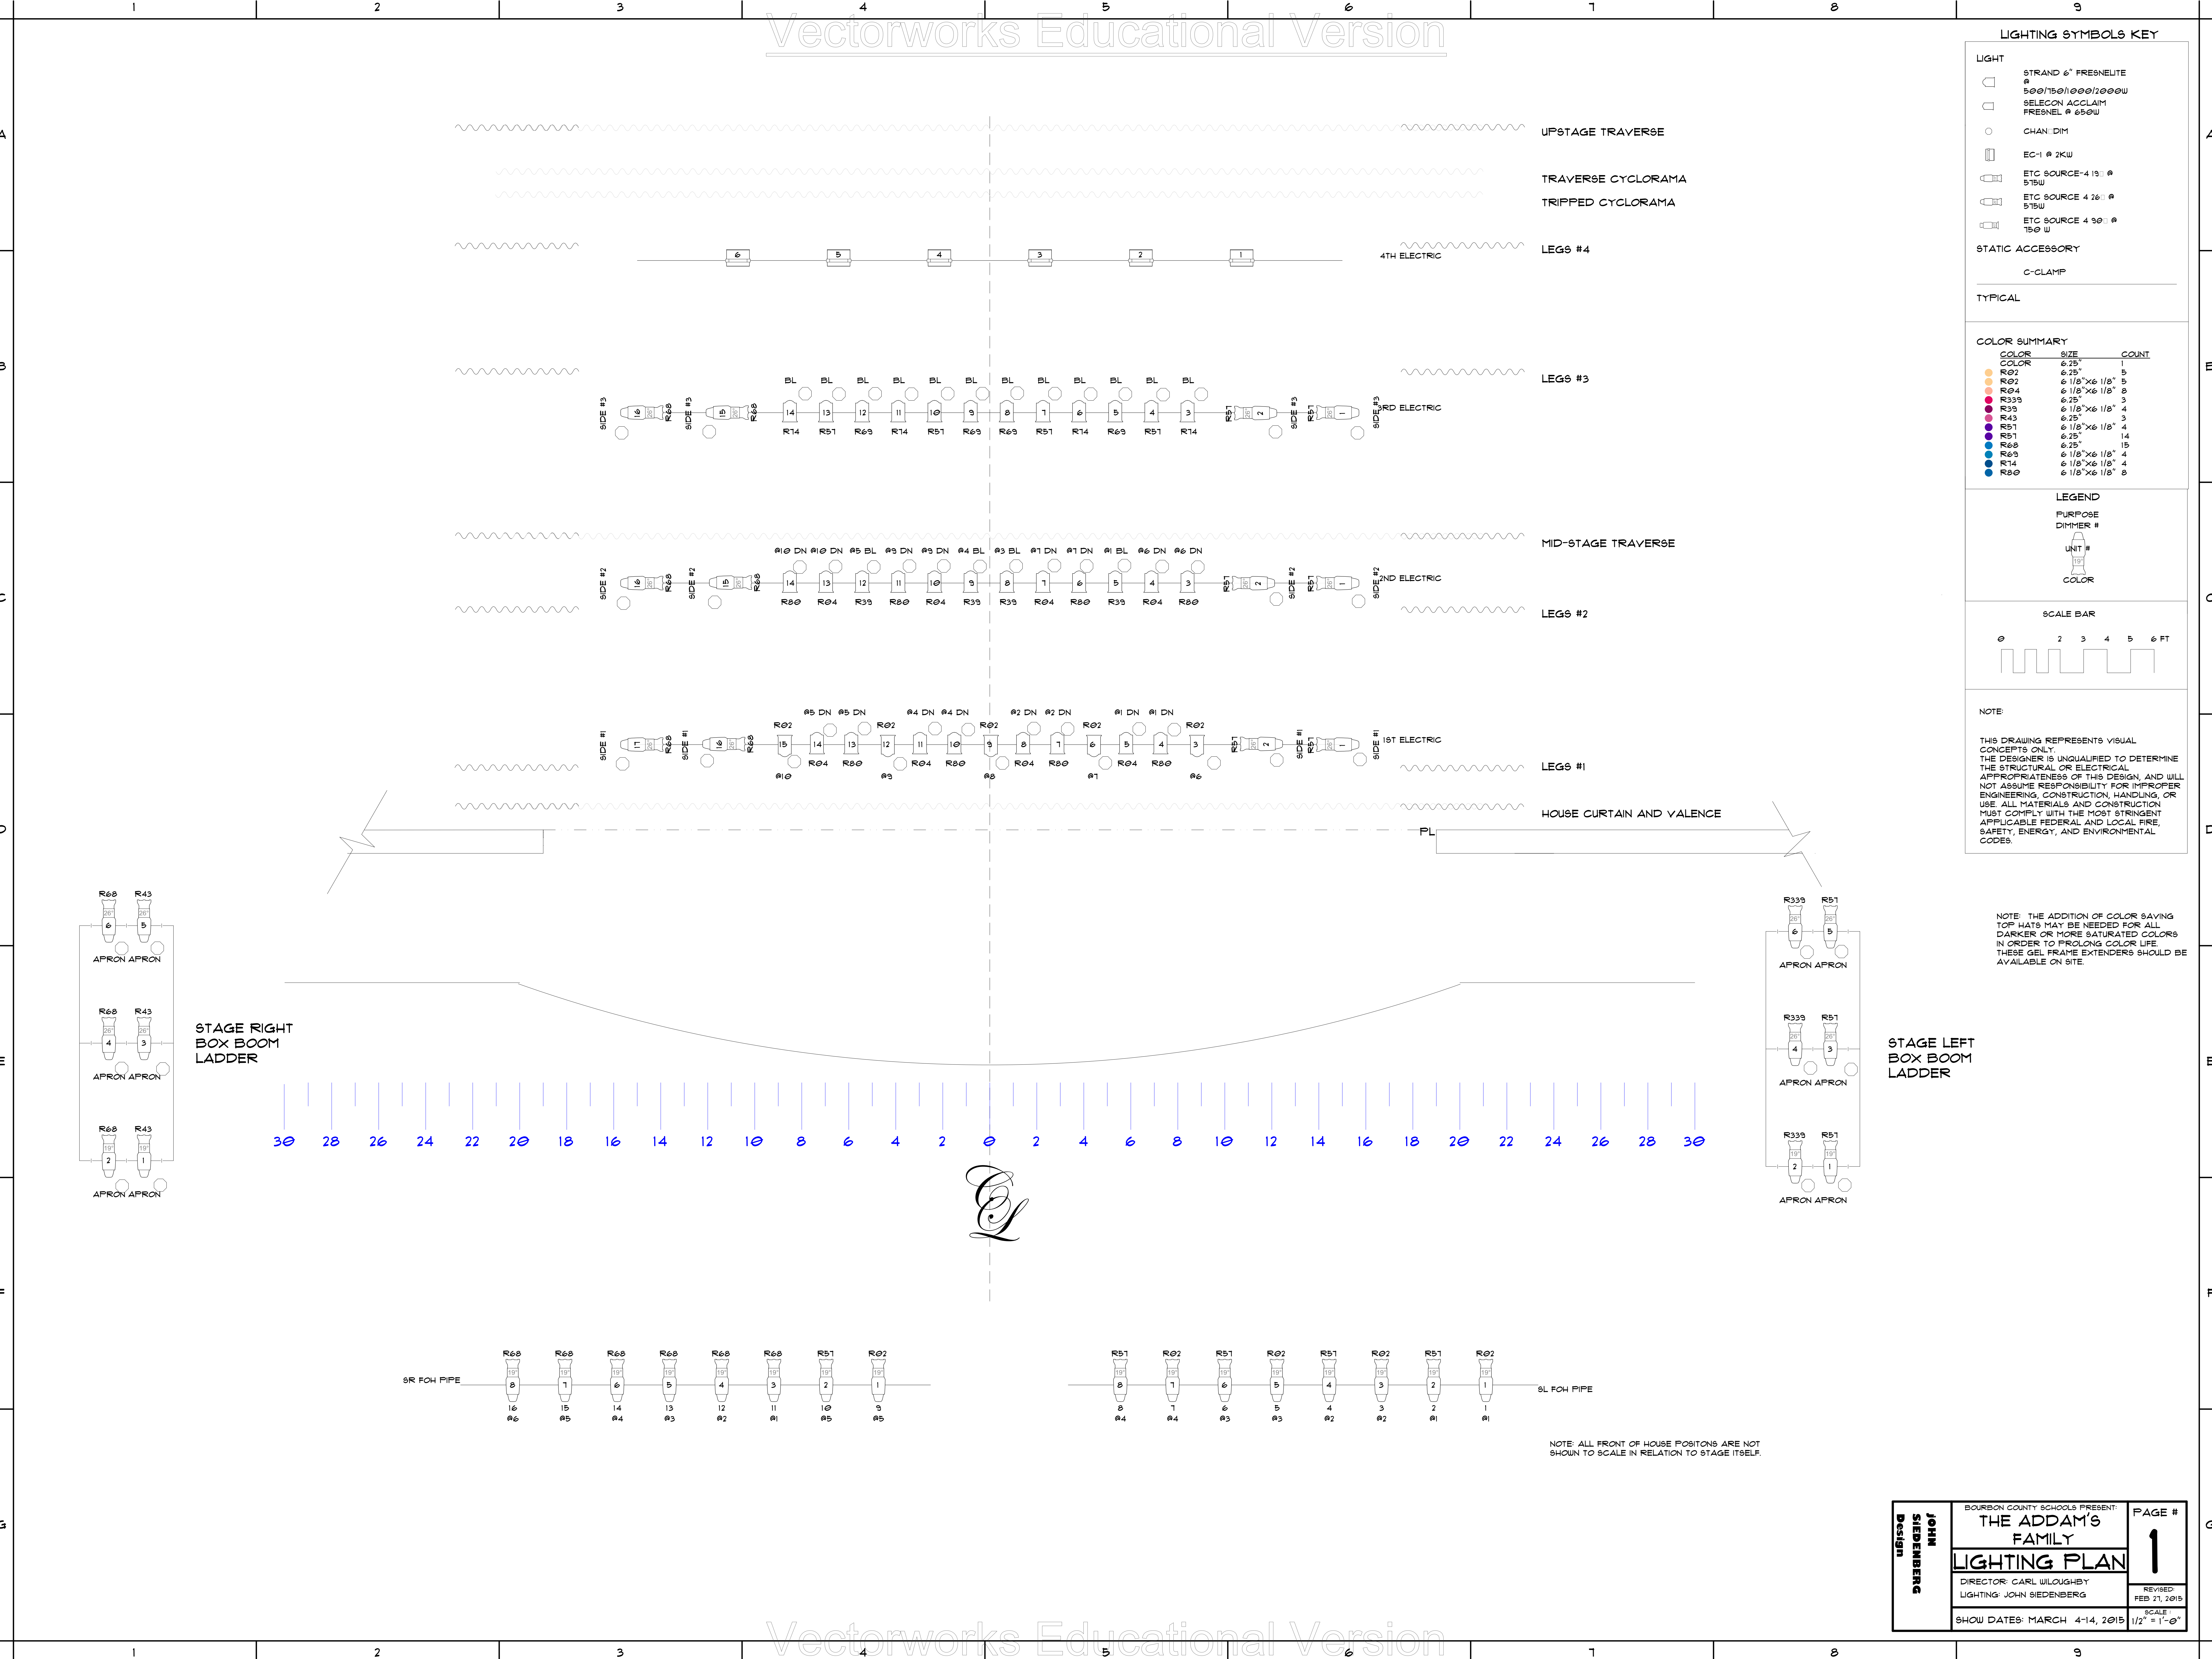

JOHN SIEDENBERG Design	BOURBON COUNTY SCHOOLS PRESENT:	PAGE #
	THE ADDAM'S FAMILY	1
	LIGHTING PLAN	REVISED FEB 21, 2015
	DIRECTOR: CARL WILLOUGHBY LIGHTING: JOHN SIEDENBERG	SCALE 1/2" = 1'-0"

SHOW DATES: MARCH 4-14, 2015